

Thematic Districts Pavilions' layouts

03/10/2018 – Moldova (MA01-B)




General Statement

The Issue For Construction drawings does not reflect any changes or alterations agreed in Shop Drawings, Request for Information, Employer Instruction and Corrective Actions due to Non-Conformance. All final fit-out design must be based on Engineer approved As Built Drawings for Assisted Pavilions, this will prevent possible abortive works and/or potential cost and time claims by the executing Contractor.

Regarding ingress/egress, please refer to the arrows in green (entrance) and red (exit) instead of the doors that appear on these Construction drawings if they are not matching.


Typical
Elevation drawings
+ Sections

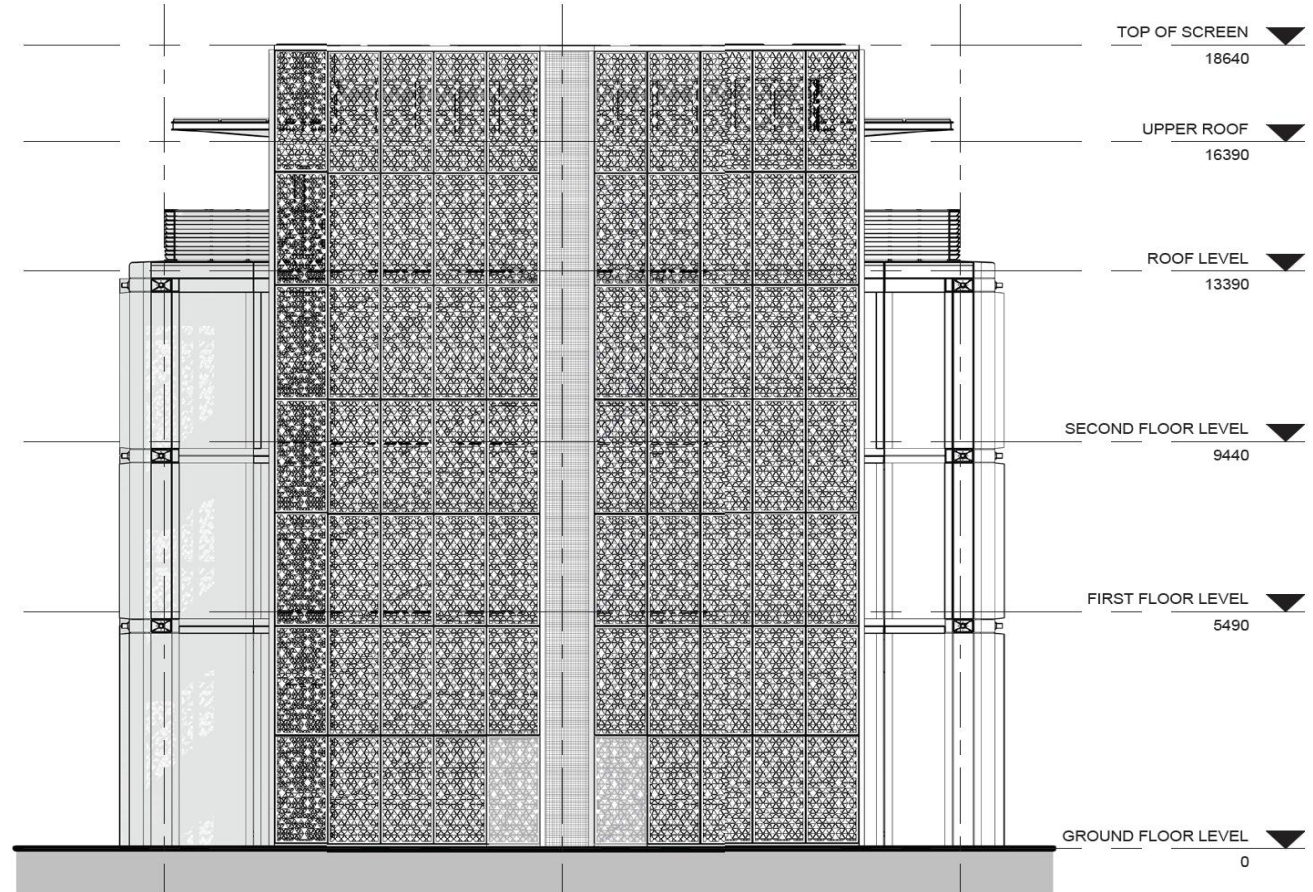


NORTH ELEVATION




EAST ELEVATION

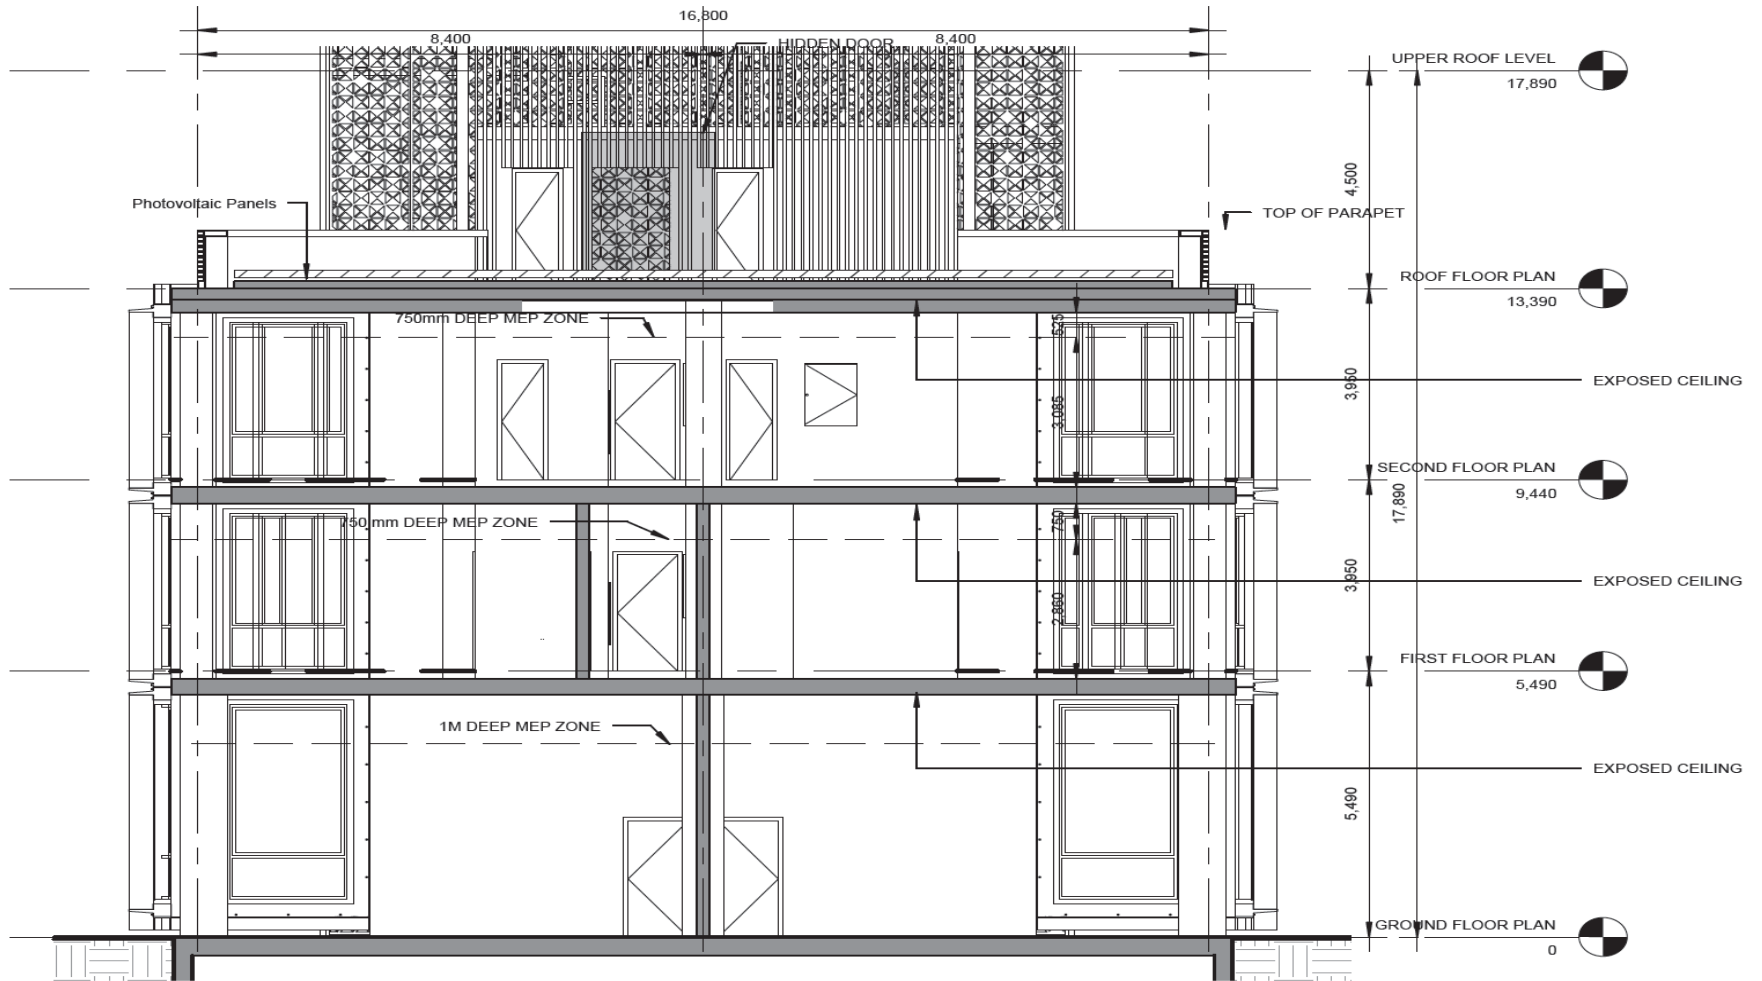


SECTION AA

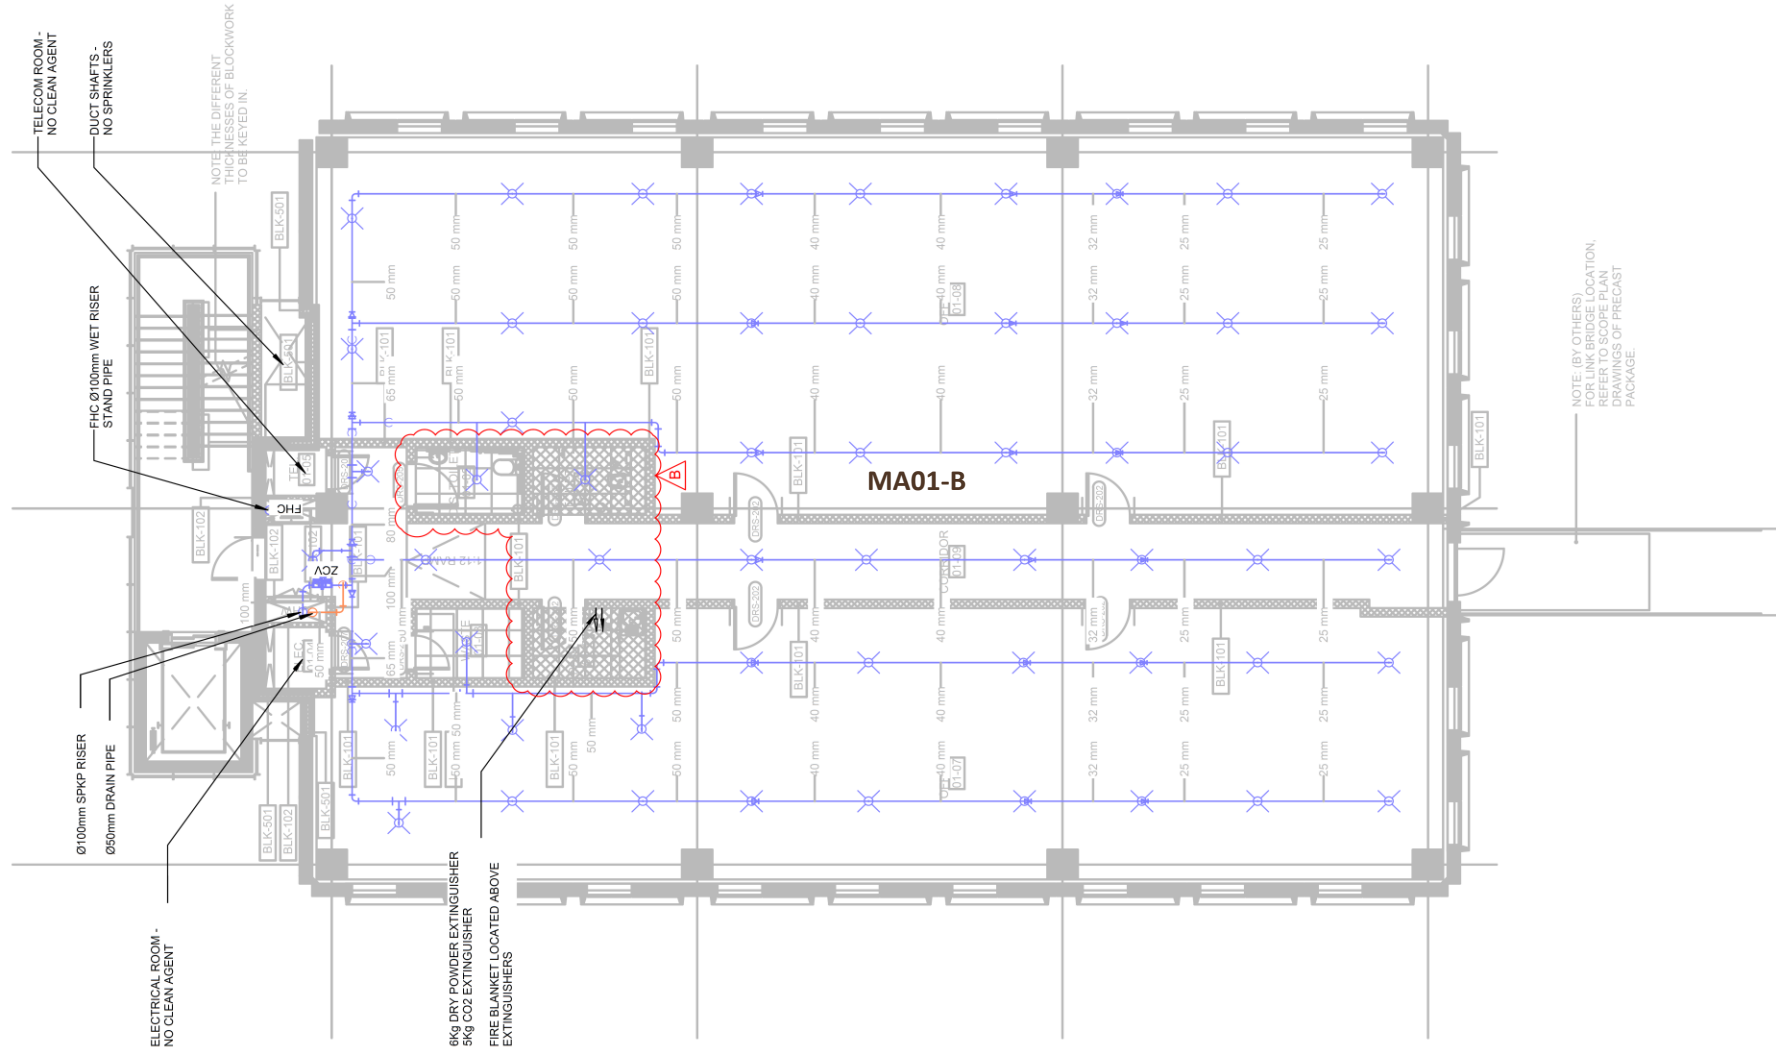

01-FIRE FIGHTING LAYOUT_A1

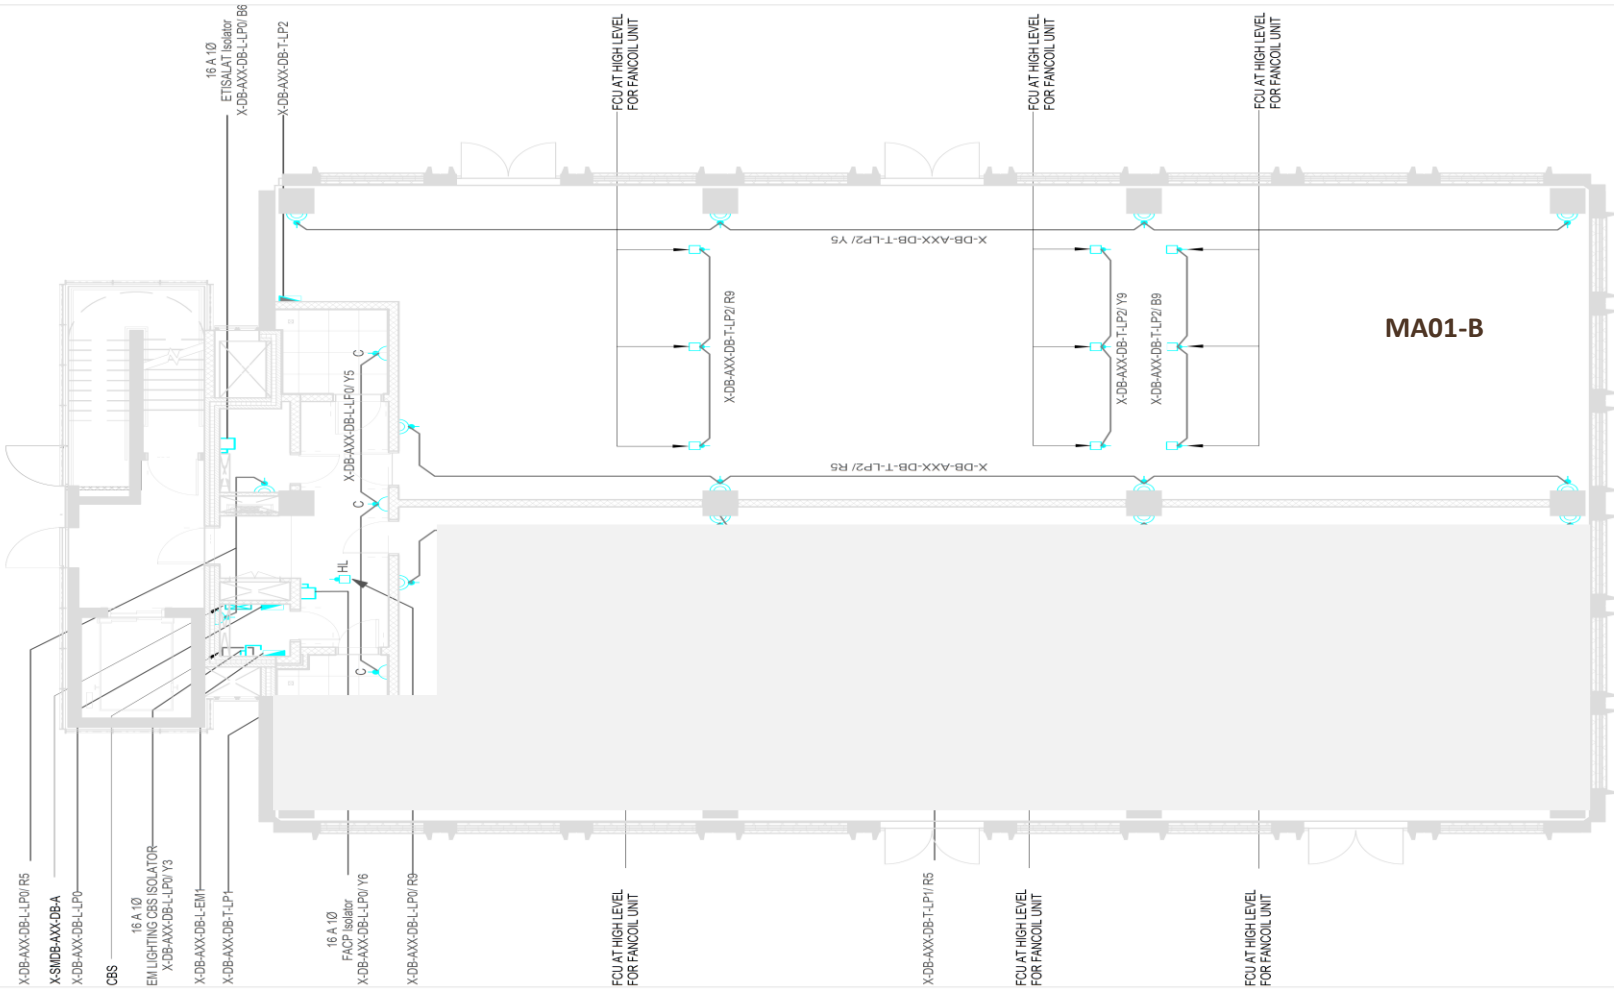

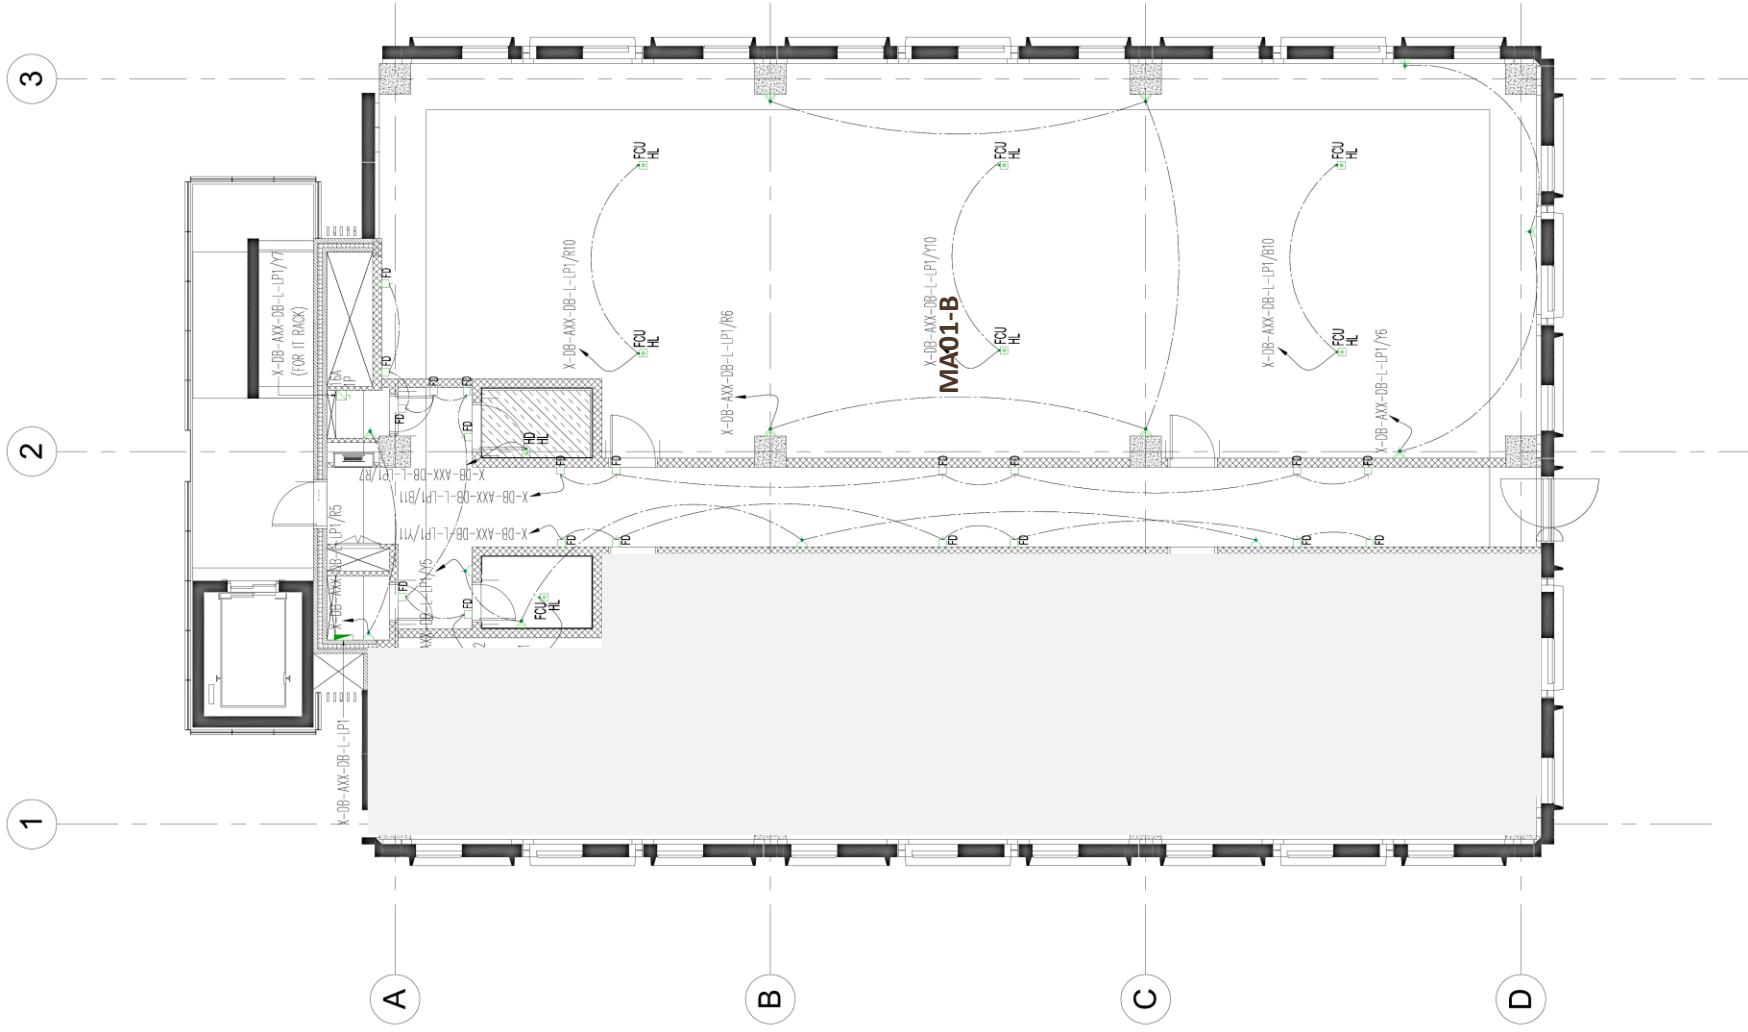


2 01 -- POWER LAYOUT A1

SCALE 1:100

3

2


1

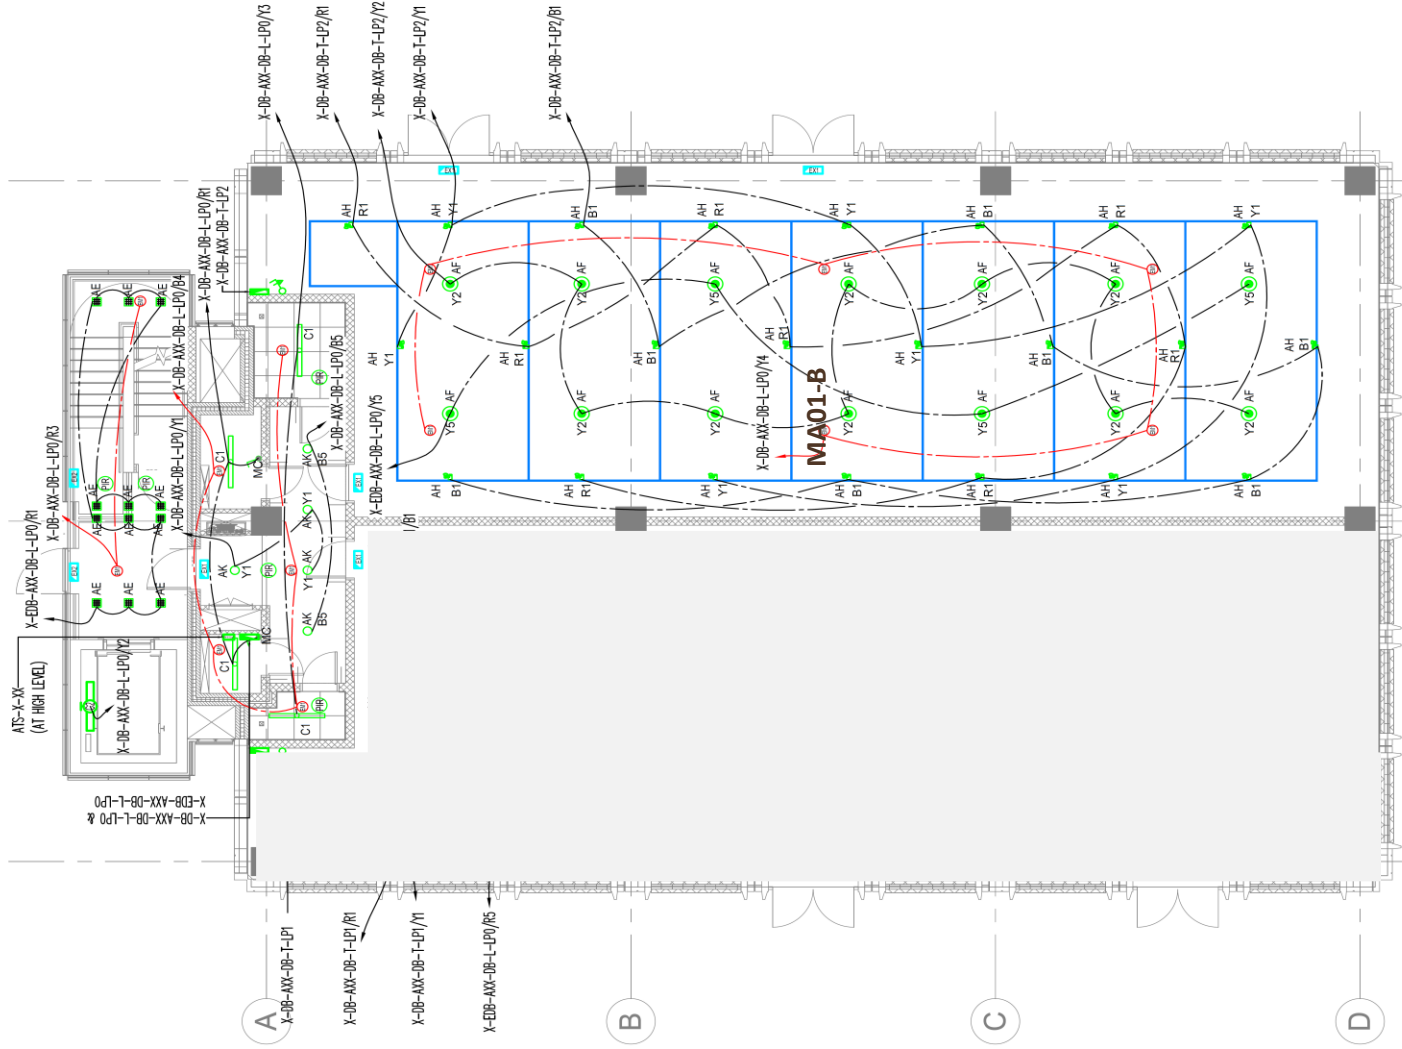

1

GF – LIGHTING LAYOUT P1


SCALE 1:100

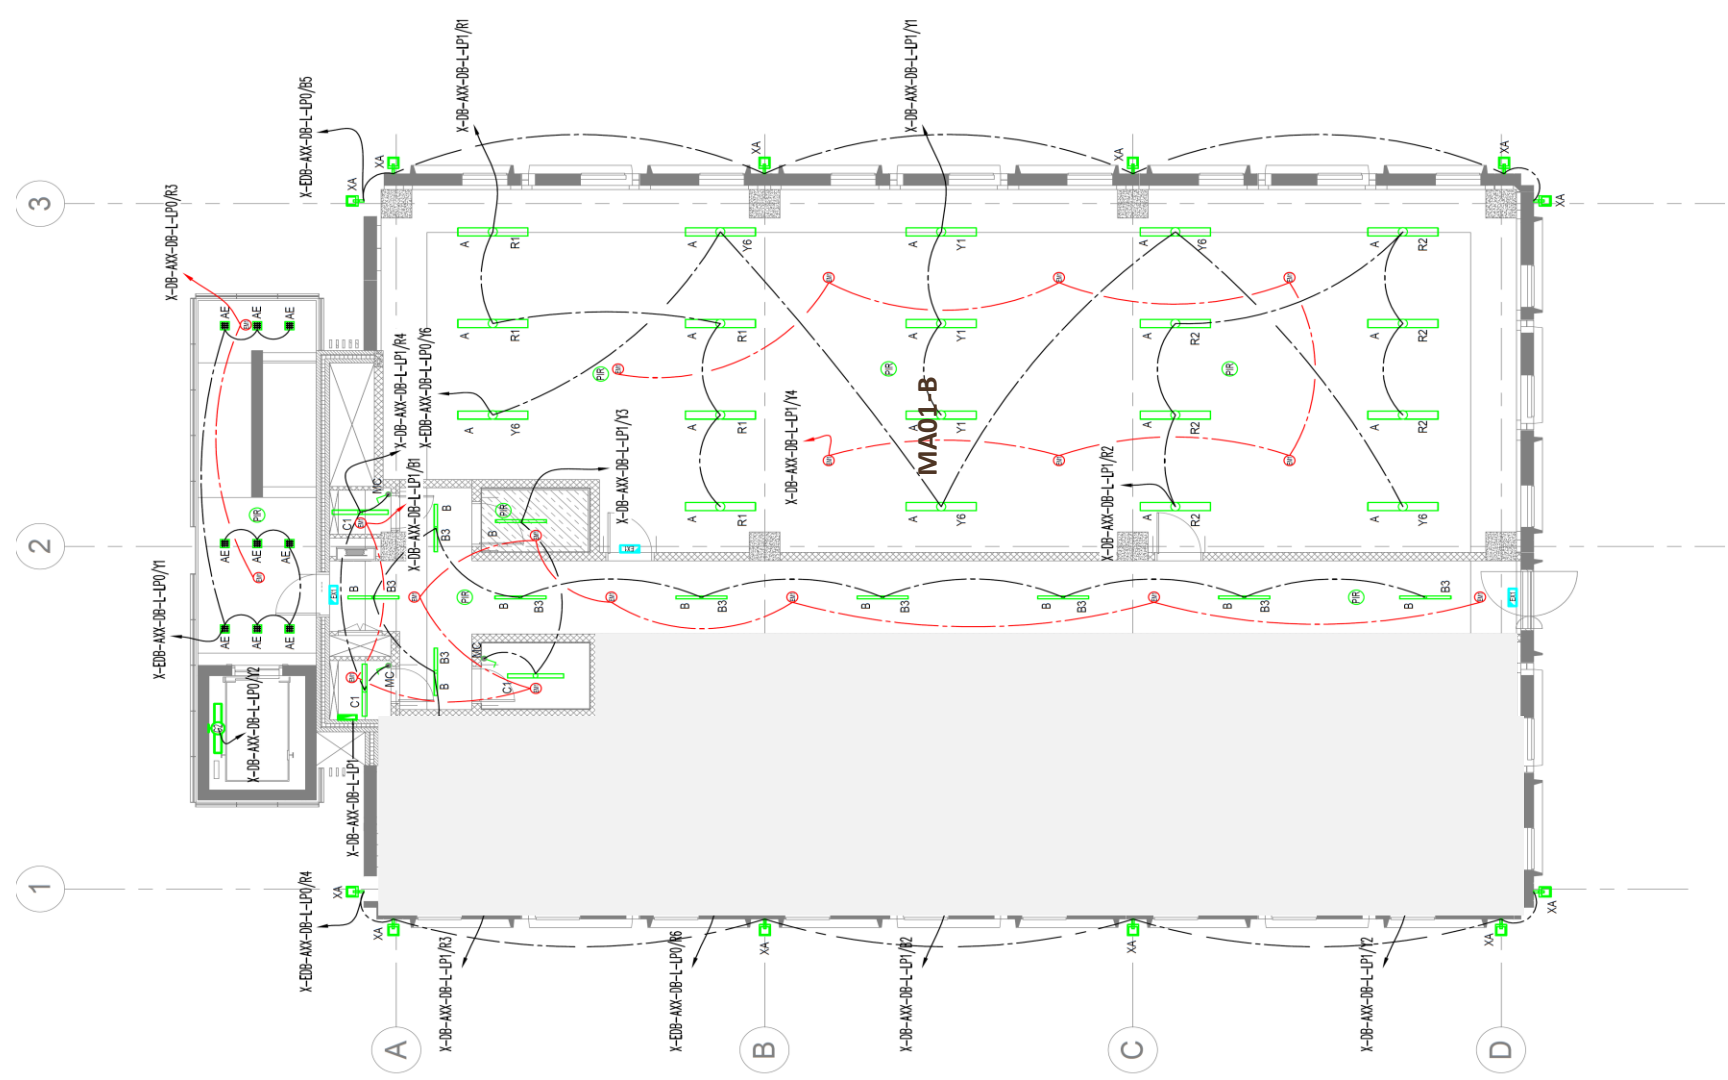

2 01 -- LIGHTING LAYOUT A1


SCALE 1:100

A-E15-X.AMP-X.CH-3
A-E15-X.AMP-X.CH-1

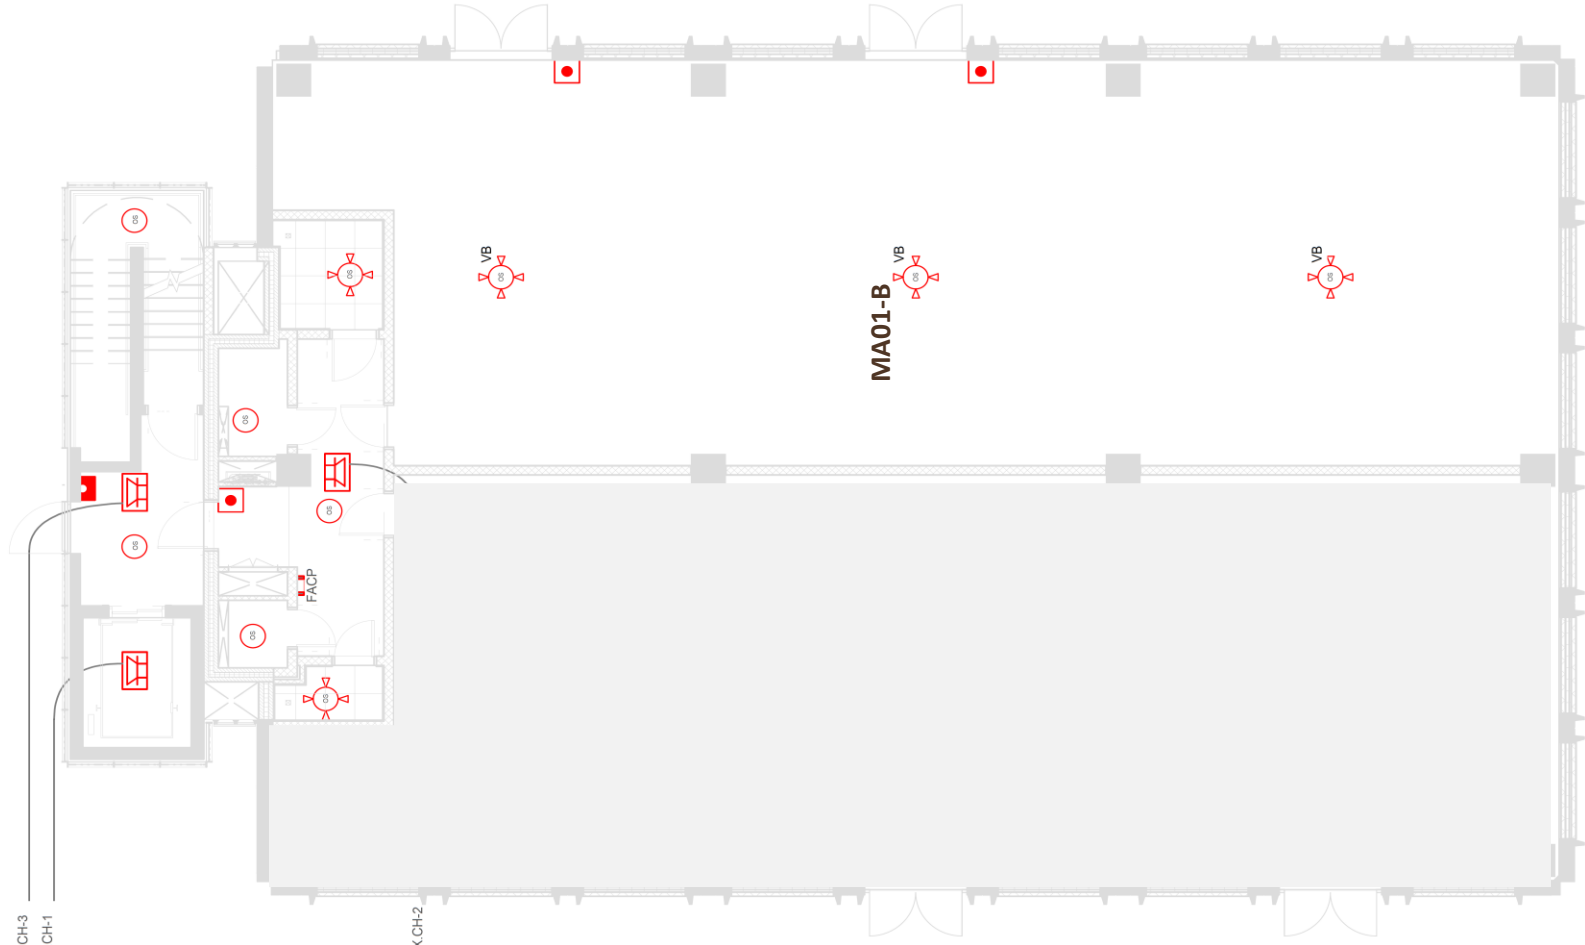

A-E15-X.AMP-X.CH-2

MA01-B^{VB}

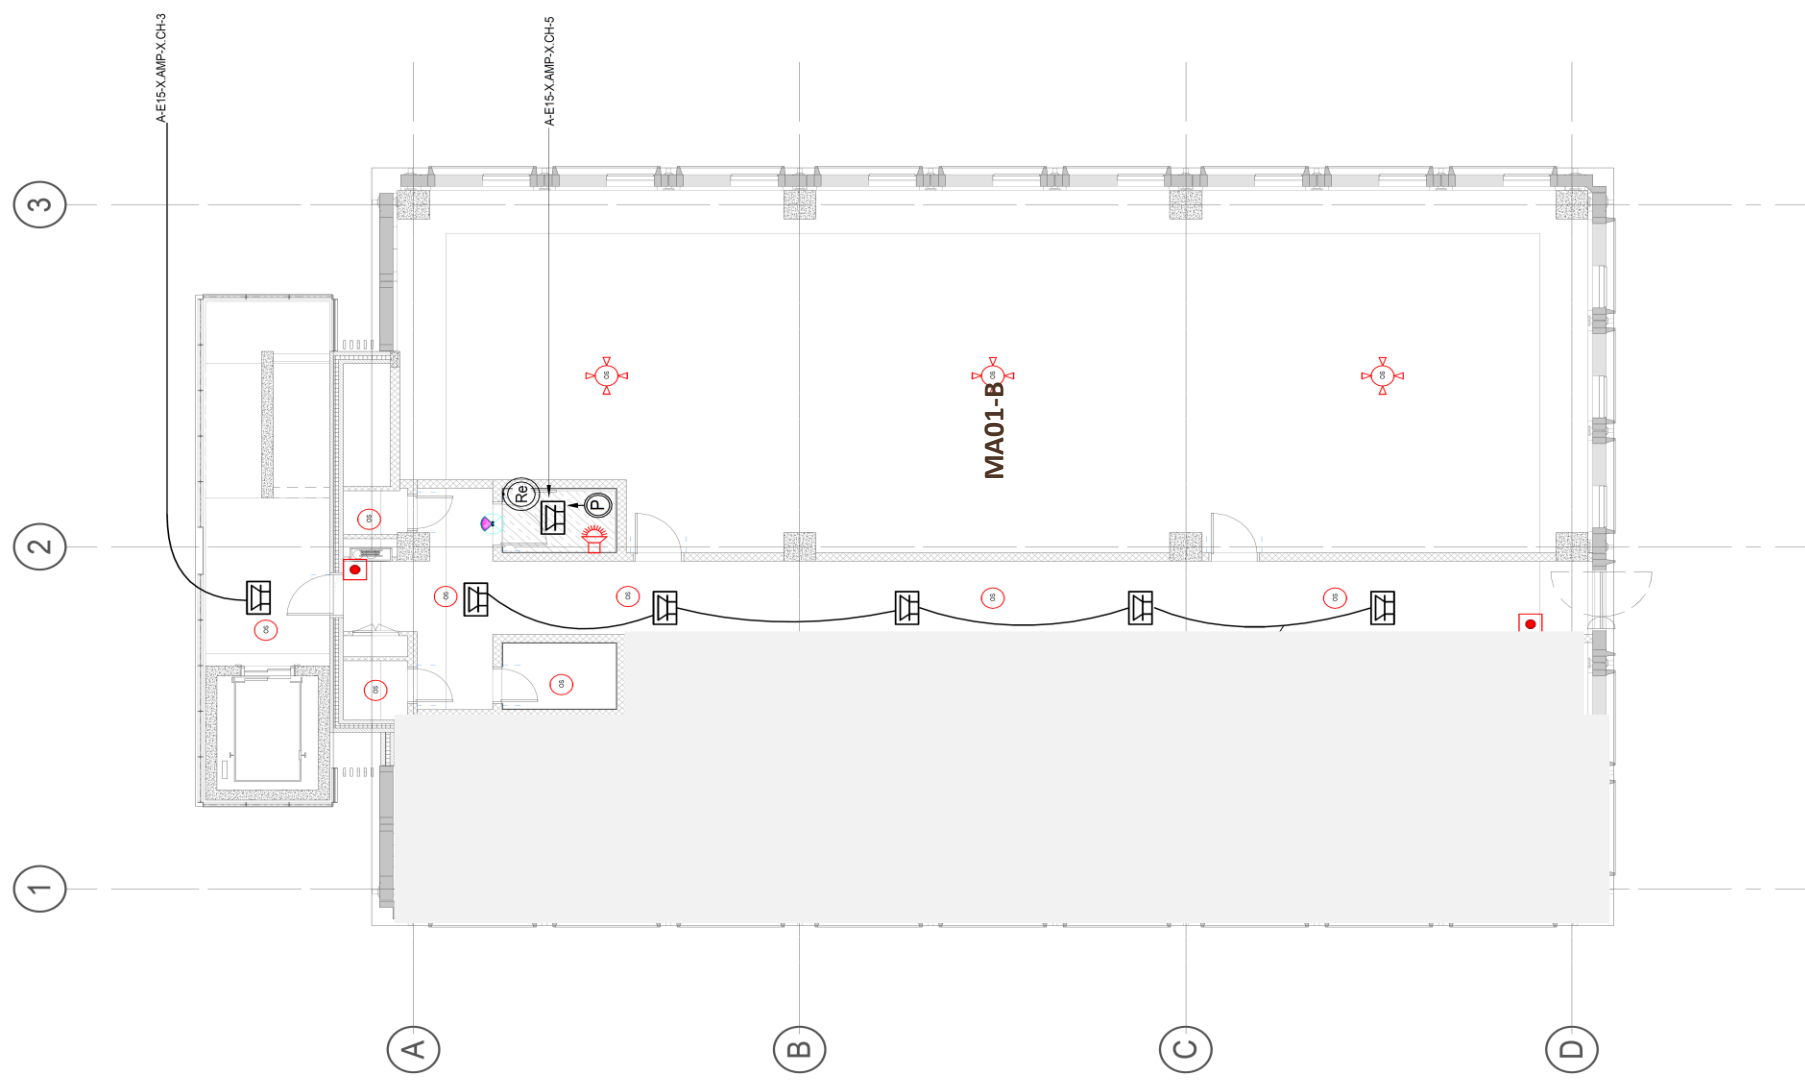

01 - FIRE ALARMS LAYOUT_A1

1 : 100